 


VASTU SILP HOME DESIGNER
 ER.A.K.ASTHANA
 ARCHITECT DESIGNER & ESTIMATE
 1/12/2019
 1/12/2019

SCALE 1:350



- ABC
- F-BUCKET
- H.R.


WATER TANK WITH HOJARI 450LPM PUMP

- FIRE EXTINGUISHER
- FIRE BUCKET
- BORING

OWNER'S SIGN.

FIRE LEGENDS

SITE PLAN

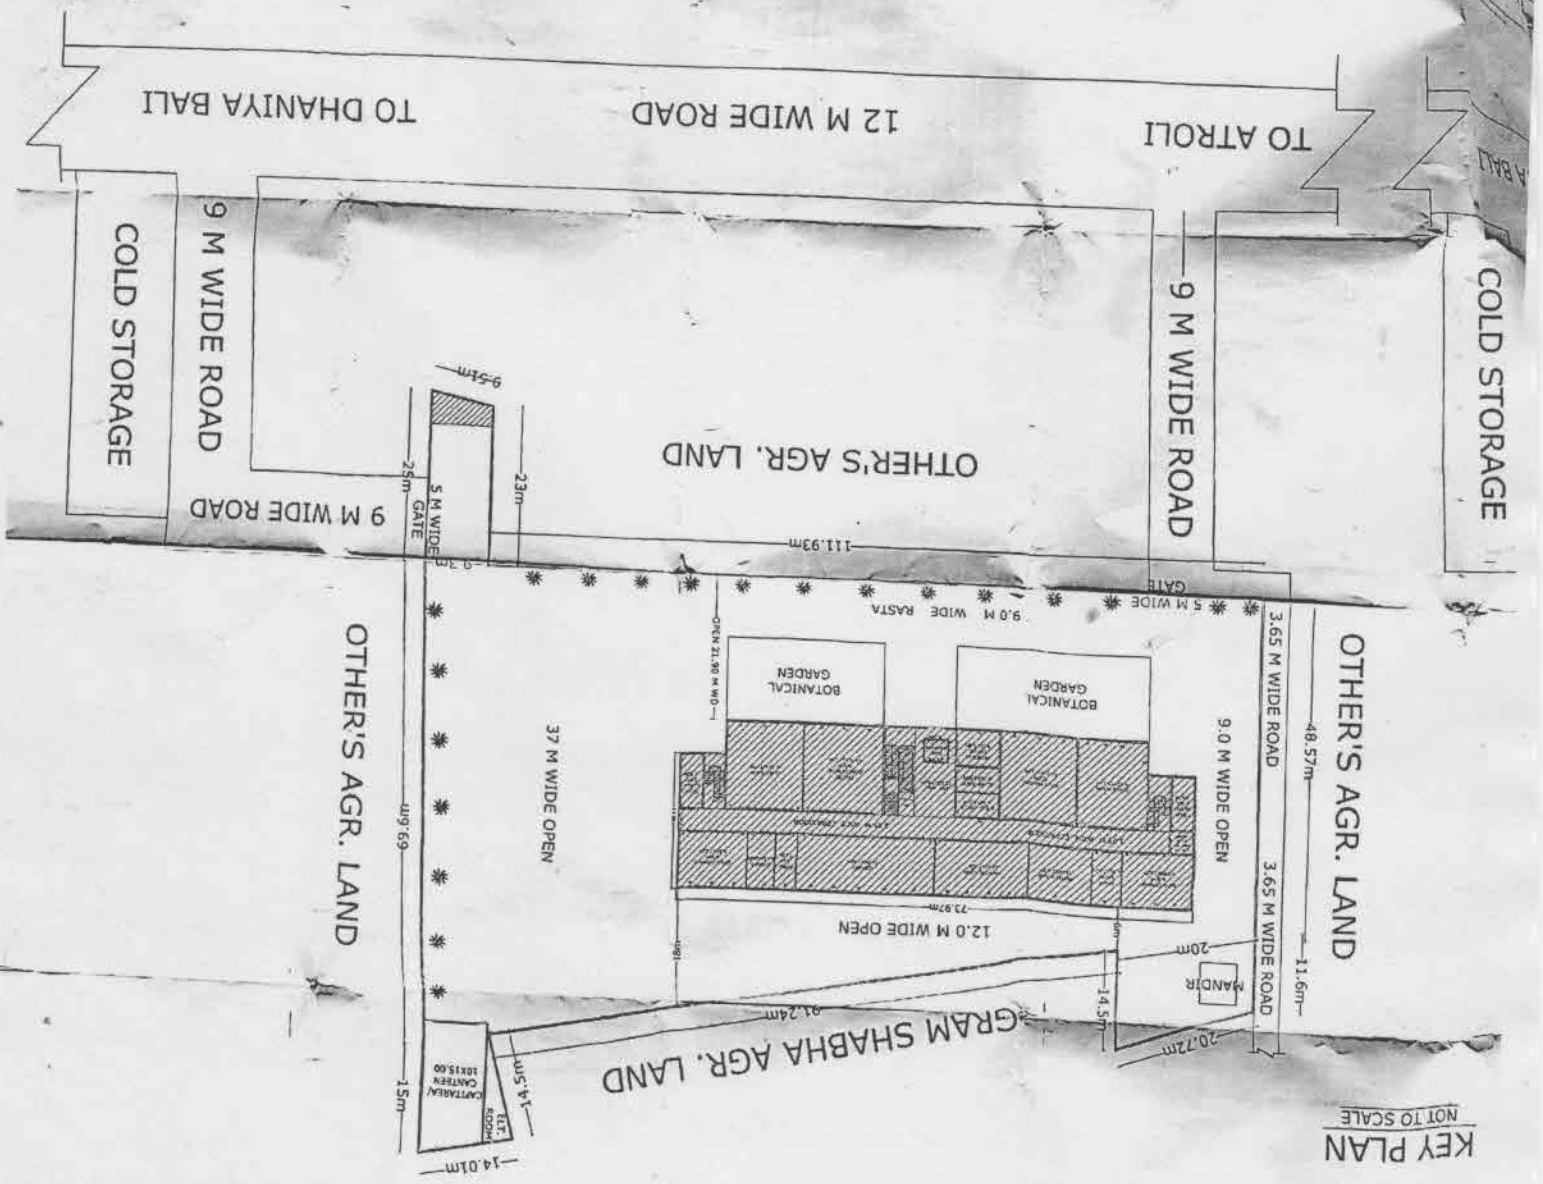

KEY PLAN
NOT TO SCALE

