



SECOND FLOOR PLAN

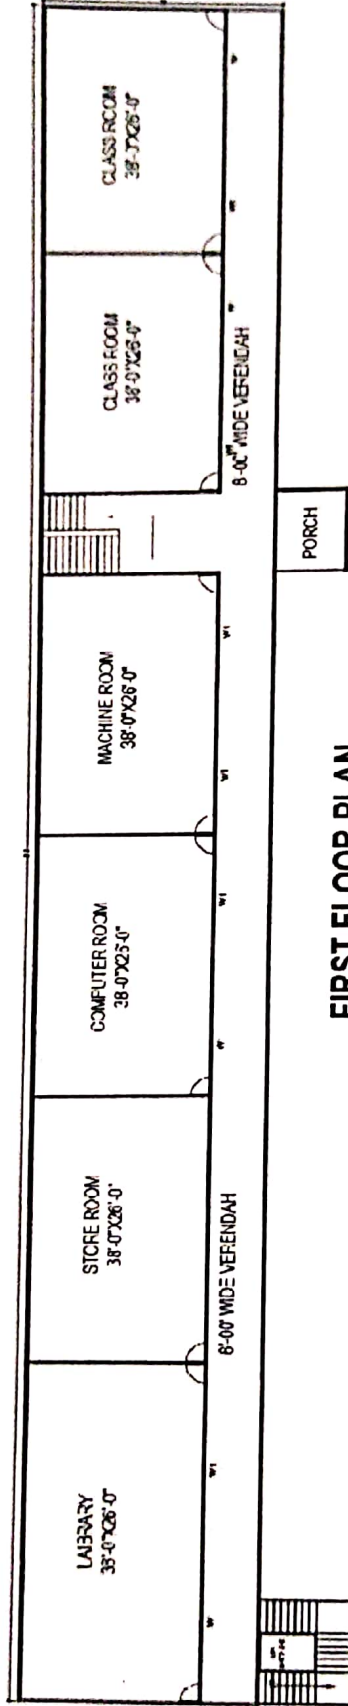

FIRST FLOOR PLAN

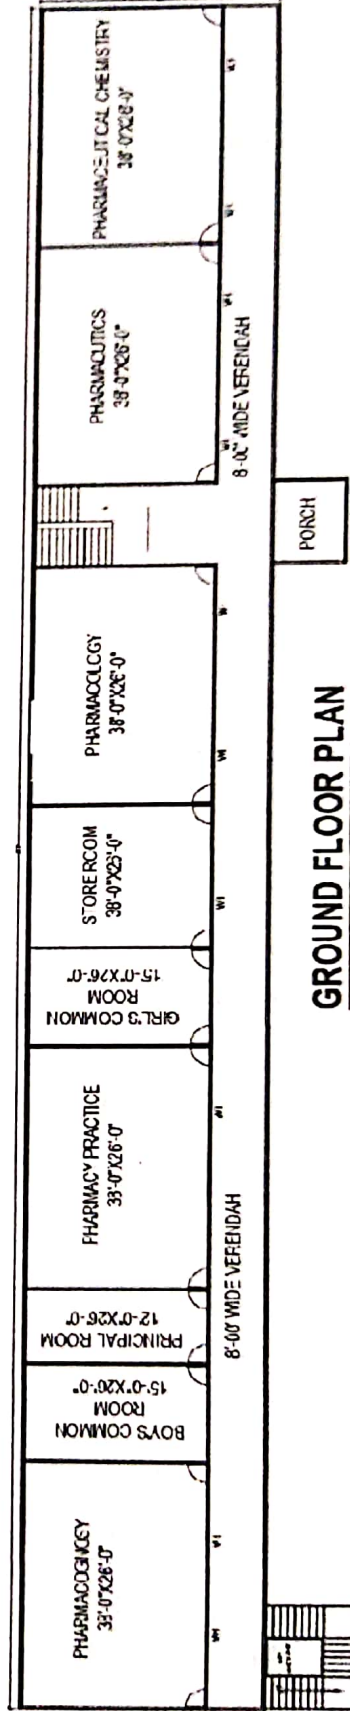

GROUND FLOOR PLAN

BABU BASANT LAL COLLEGE OF PHARMACY

SALEMPIUR BASGIT, HAND A, PRAYAGRAJ

PROJECT BABU BASANT LAL COLLEGE OF PHARMACY	DATE OCT 24 2022	ARCHITECTS Pankaj Kumar Singh (Architect) COA No. -CA/2016/80349
DRAWN BY ARTHUR SH PAL	CHECKED BY AF PANJAGRAJ SINGH	
3RD FLOOR ARCHITECTURAL PLAN (GROUND FLOOR & SECOND FLOOR PLAN)		