





WATER RECHARGING PIT
NOT TO SCALE
SCALE: 1:100

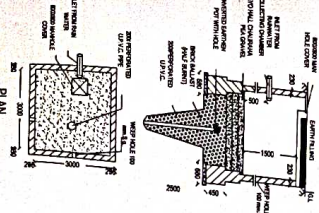

GROUND FLOOR PLAN
SCALE - 1:100

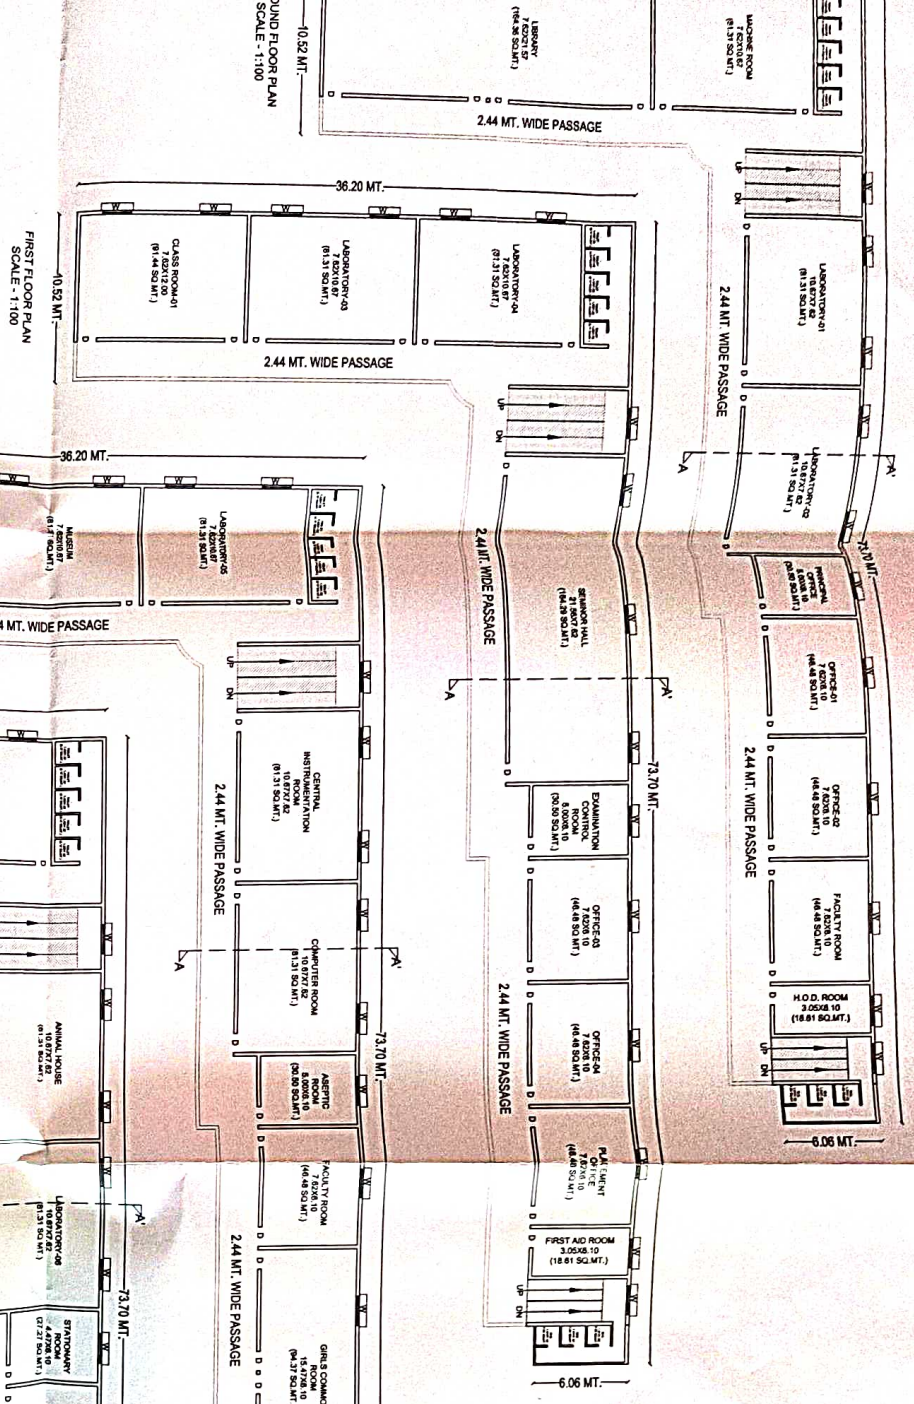

FIRST FLOOR PLAN
SCALE - 1:100

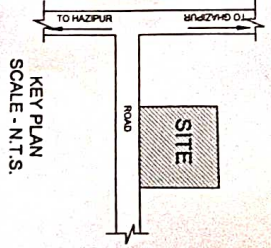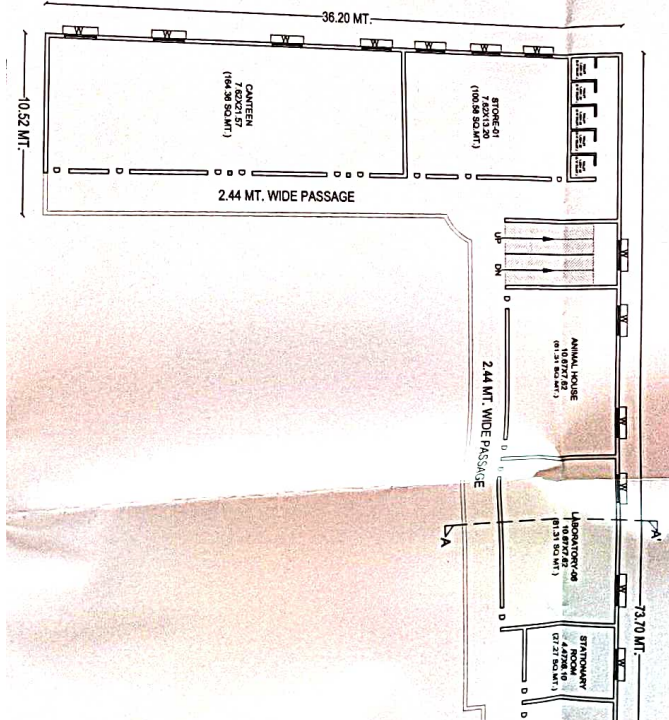

KEY PLAN
SCALE - N.T.S.

SECTION A-A
SCALE - 1:50

